

SHEET INDEX

- A1 FLOOR PLAN & ROOM FINISH SCHEDULE
- A2 REFLECTED CEILING PLAN
- A3 ELECTRICAL PLAN
- A4 EAST & WEST EXTERIOR ELEVATIONS
- A5 BUILDING SECTION, SOUTH & NORTH ELEVATIONS

These plans are an instrument of service and are the property of the Architect, and may not be duplicated, disclosed, or reproduced without the written consent of the Architect. Copyrights and Infringements will be enforced and prosecuted.

**DNA**  
 DAN NAIMAN ARCHITECTURE  
 104 MILL STREET  
 BAYFIELD, CO 81122  
 (970) 905-4002  
 DANA@DNADESIGNS.NET

FOREST LAKES METRO DISTRICT  
 COMMUNITY CENTER  
 998 ALPINE FOREST DR. / BAYFIELD, COLORADO

FLOOR PLAN

DATE ISSUED:  
4-1-20


DRAWN BY:  
CE

CHECKED BY:  
DNA

REVISIONS

NO.	DESCRIPTION

A=1

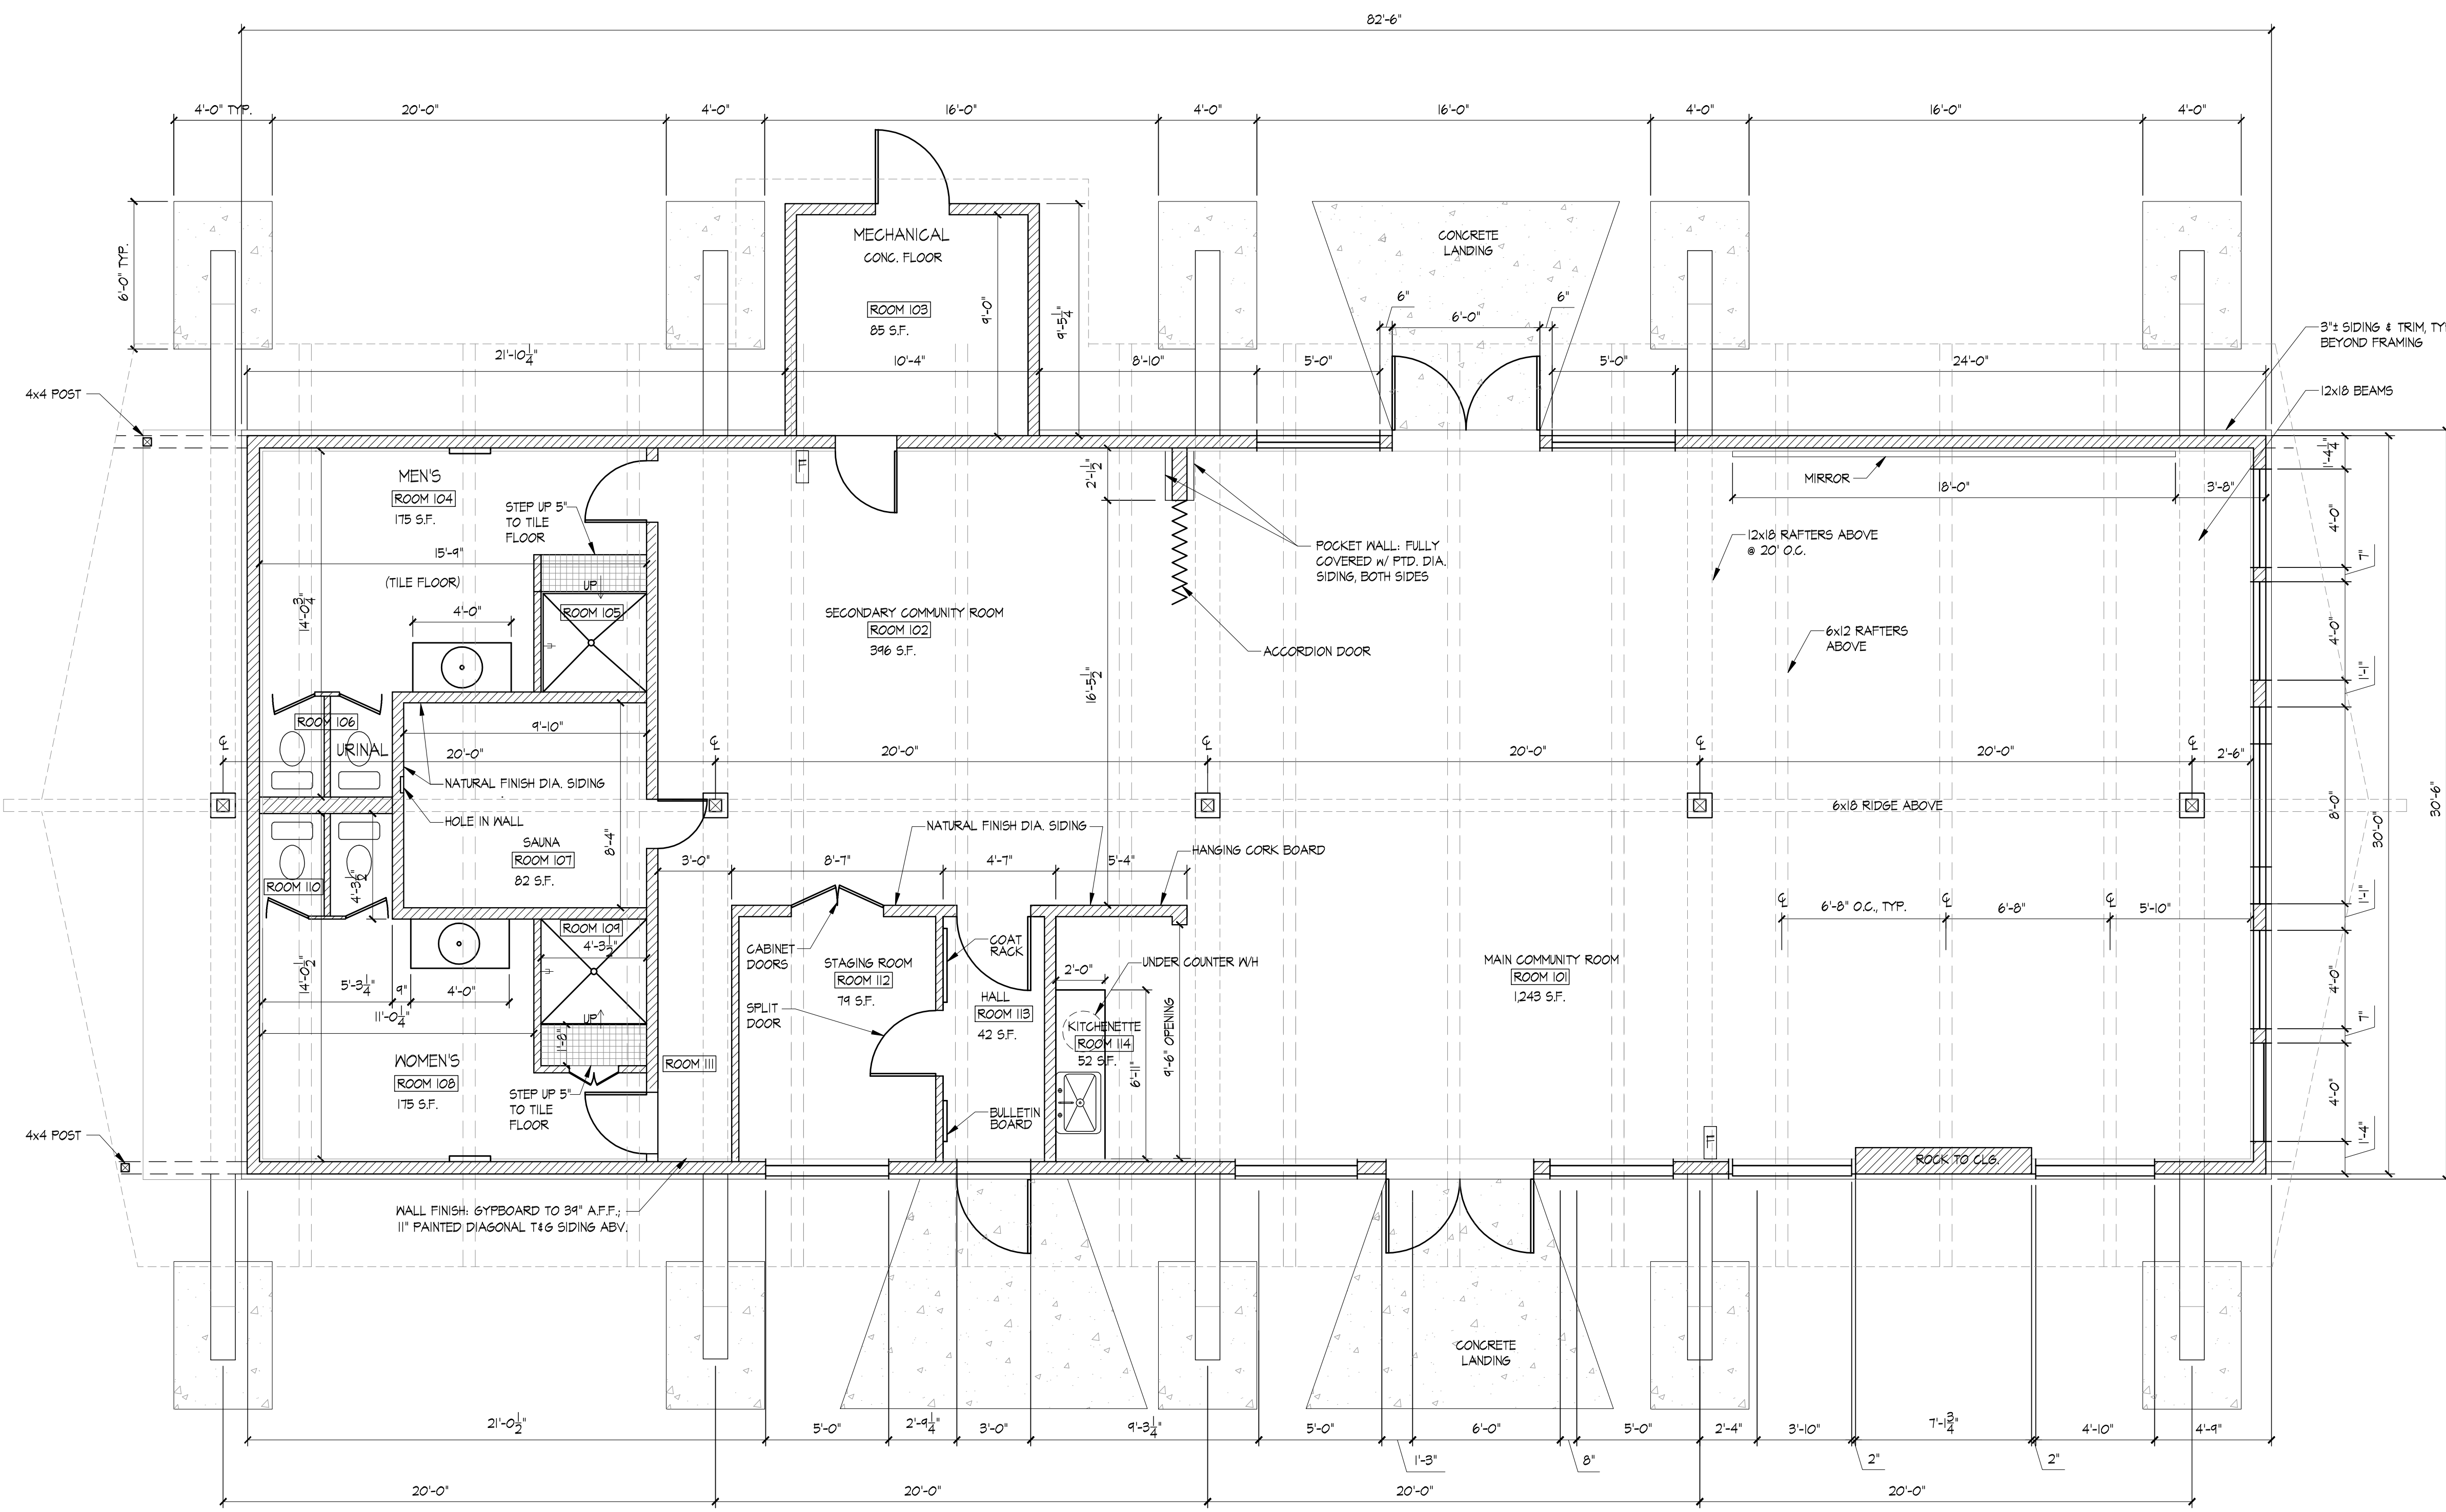

**1 FLOOR PLAN**  
 1/4"=1'-0"

ROOM FINISH SCHEDULE						
ROOM #	ROOM	FLOOR	WALLS - MAINSCOAT	WALLS - UPPER	CEILING	REMARKS
101	MAIN COMMUNITY ROOM	CARPET	PTD. GYP BOARD TO 34" A.F.F.	1x12 PAINTED DIAGONAL SIDING	PAINTED 2x6 T&G	
102	SECONDARY COMMUNITY ROOM	CARPET	PTD. GYP BOARD TO 34" A.F.F.	1x12 PAINTED DIAGONAL SIDING	PAINTED 2x6 T&G	
103	MECHANICAL ROOM	CONCRETE	GYP. BOARD & WOOD SIDING		PAINTED 2x6 T&G	
104	MEN'S BATH	4x8 BRICK PAVERS	4x4 CERAMIC TILE TO 34" A.F.F.	1x12 PAINTED DIAGONAL SIDING	PAINTED 2x6 T&G	
105	MEN'S SHOWER	1x1 CERAMIC TILE STEP TO VINYL SHOWER UNIT	PRE-MANUFACTURED VINYL UNIT	1x12 PAINTED DIAGONAL SIDING ABOVE PRE-MANUFACTURED VINYL UNIT	PAINTED 2x6 T&G	
106	MEN'S WATER CLOSET	4x8 BRICK PAVERS	4x4 CERAMIC TILE TO 34" A.F.F.	1x12 PAINTED DIAGONAL SIDING	DROP CEILING w/ PAINTED GYP BOARD	WALLS BEHIND TOILET & URINAL: 4x4 TILES TO 44" A.F.F.
107	PREVIOUS SAUNA	CONCRETE	PTD. GYP BOARD TO 34" A.F.F.	1x12 PAINTED HORIZONTAL SIDING	DROP CEILING w/ PAINTED LUMBER	
108	WOMEN'S BATH	4x8 BRICK PAVERS	4x4 CERAMIC TILE TO 34" A.F.F.	1x12 PAINTED DIAGONAL SIDING	PAINTED 2x6 T&G	
109	WOMEN'S SHOWER	1x1 CERAMIC TILE STEP TO VINYL SHOWER UNIT	PRE-MANUFACTURED VINYL UNIT	1x12 PAINTED DIAGONAL SIDING ABOVE PRE-MANUFACTURED VINYL UNIT	PAINTED 2x6 T&G	
110	WOMEN'S WATER CLOSET	4x8 BRICK PAVERS	4x4 CERAMIC TILE TO 34" A.F.F.	1x12 PAINTED DIAGONAL SIDING	DROP CEILING w/ PAINTED GYP BOARD	
111	HALL TO WOMEN'S BATH	CARPET	1x12 PAINTED DIAGONAL SIDING	1x12 PAINTED DIAGONAL SIDING	PAINTED 2x6 T&G	
112	STAGING ROOM	12x12 VCT	PAINTED GYP BOARD OVER ALL		PAINTED 2x6 T&G	
113	HALL TO EXTERIOR DOOR	CARPET	PAINTED GYP BOARD OVER ALL		PAINTED 2x6 T&G	
114	KITCHENETTE	CARPET	PAINTED GYP BOARD OVER ALL		PAINTED 2x6 T&G	